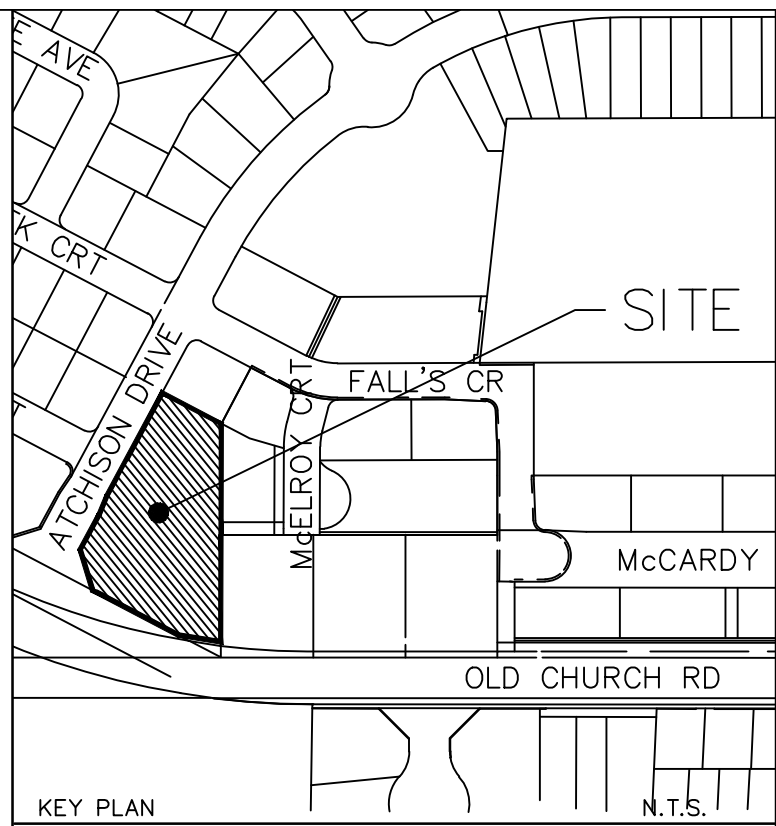
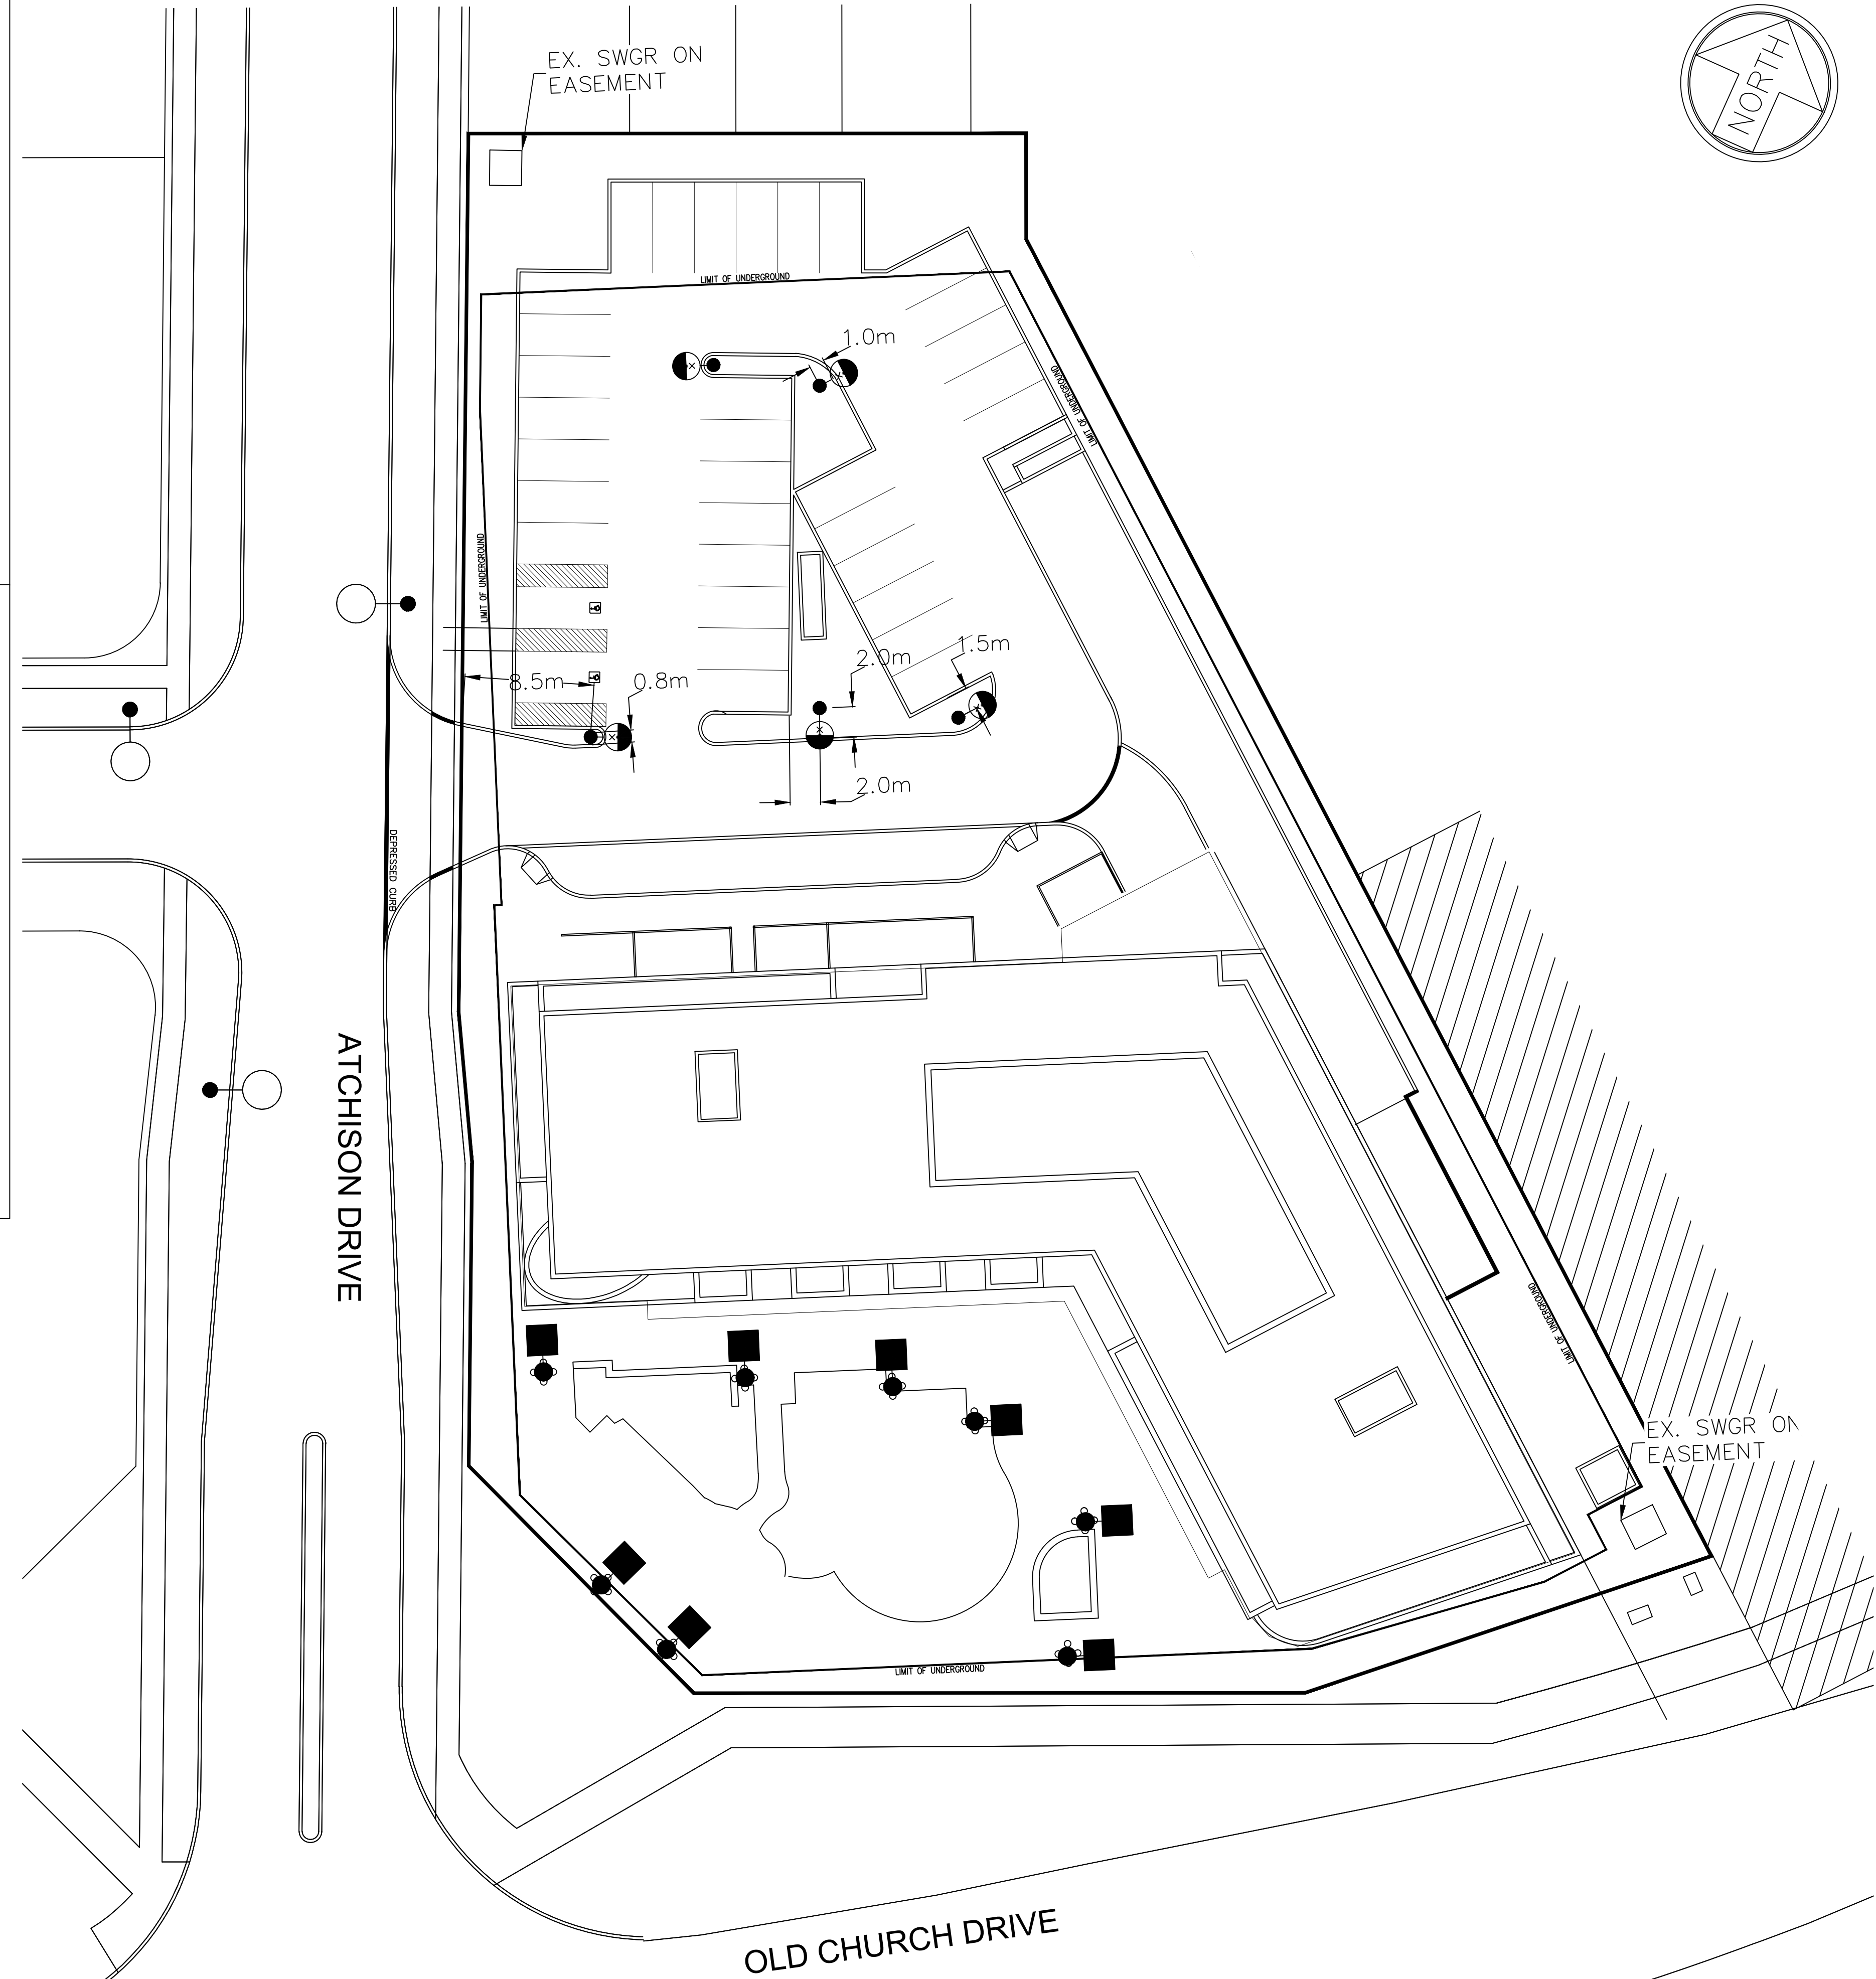
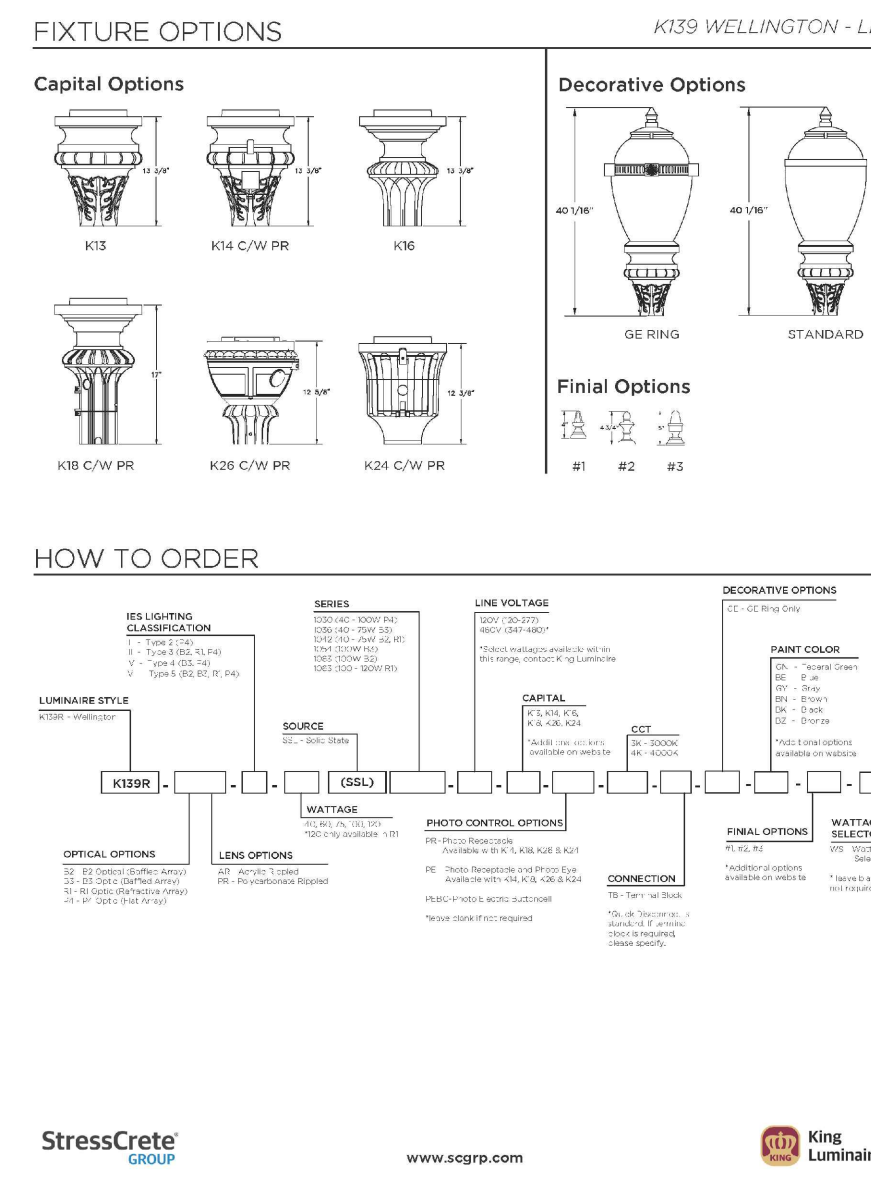
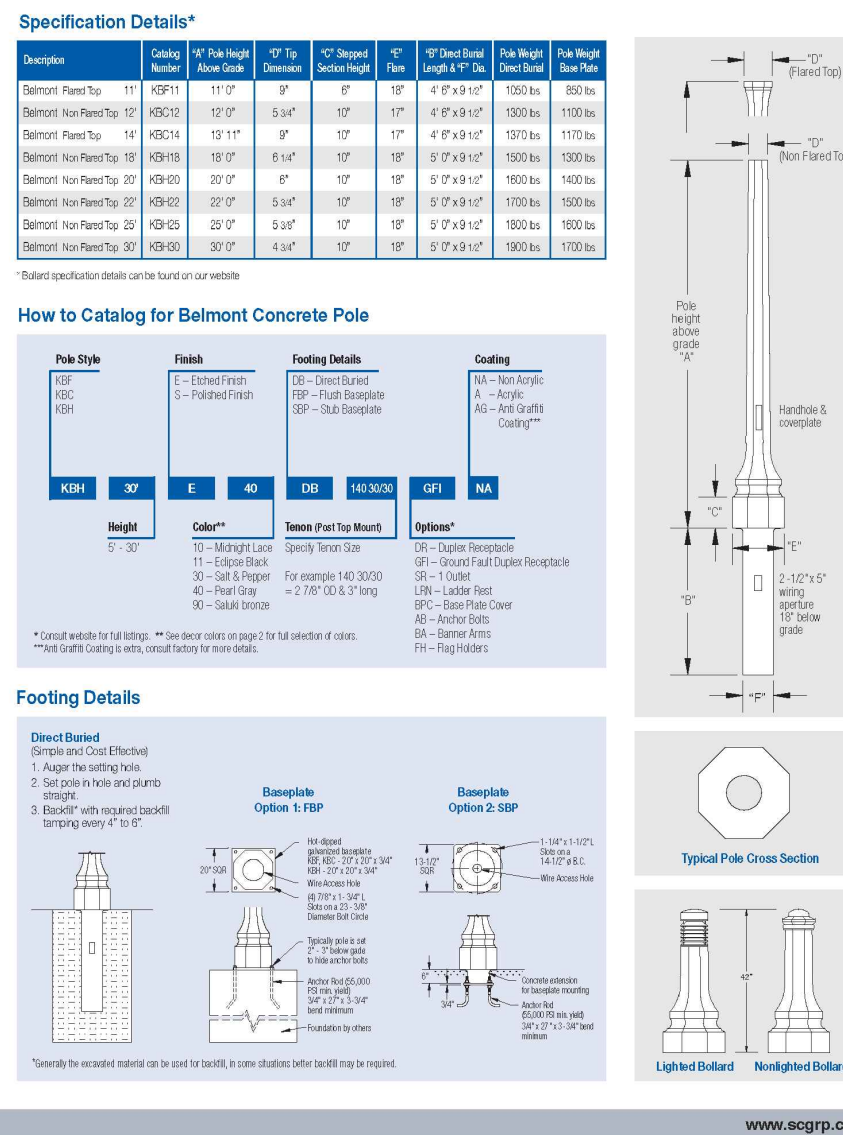
[illegible]

STREETLIGHT POLE: 6.7m (22.0')
SQUARE CONCRETE POLE (B.Y.)
STRESS-CRETE
CAT.#P220-AAPS-G-S11 S/F 130
C/W BPC-1 FINISHED IN POLISHED
ECLIPSE
LUMINAIRE: GE EVOLVE SERIES
EALS-03-0-02-SM-7-30-N-A-D1-BLK
50W 120V L.E.D. C/W PHOTO
CONTROL. NOTE: LUMINAIRE
FACTORY FINISHED POWDER COAT
BLACK.
PHOTOMETRIC FILE:
EALP03_C2AN730J05

DECORATIVE POLE: 5.4m (18.0')
BELMONE CONCRETE BASE-MOUNT,
PRE-STRESSED
STREETLIGHTING POLE, FINISHED
POLISHED BLACK ECLIPSE.
KBH18-E11-FBP-140 30/30-A
LUMINAIRE: K139 WELLINGTON 50W LED
C/W PHOTOCONTROL, BLACK, PER
PHOTOMETRIC FILE
0100SP4AR4X04030XXJIES
CAT: K139R-P4R-V-40-SSL-120-K16
PEBC-3K-BK-3.


APPROVED FOR CONSTRUCTION
THIS APPROVAL CONSTITUTES A GENERAL REVIEW AND DOES NOT
CERTIFY DIMENSIONAL ACCURACY.

THIS APPROVAL IS SUBJECT TO THE FURTHER CERTIFICATION OF
THE "AS CONSTRUCTED" WORKS BY A REGISTERED PROFESSIONAL
ENGINEER OF THE PROVINCE OF ONTARIO.

DATE : _____ APPROVED BY: _____

R2	REVISED PER LATEST SITE PLAN	2020.06.25	T.J.G.
R1	REVISED PER LATEST SITE PLAN	2019.04.30	T.J.G.
NO.	REVISION	DATE	BY



 **RTG SYSTEMS INC.**
ELECTRICAL CONSULTING ENGINEERS

3518 Mainway Dr., Suite 201 Office: (905) 335-4470
BURLINGTON ON L7M 1A8 Toronto: (905) 827-7887
E-MAIL: general@rtgsystems.com

TOWN OF CALEDON

PLURIBUS CORP.
0 ATCHISON DR., CALEDON
RZ 18-03, SPA 18-06
SITE LIGHTING PLAN

DWG BY T.J.G.	DATE 2018.02.14	CK'D BY	DATE 2020.06.25
SCALE 1: 250 EXCEPT SYMBOLS		DRAWING NO. SL-1	SHEET 1 OF 1