
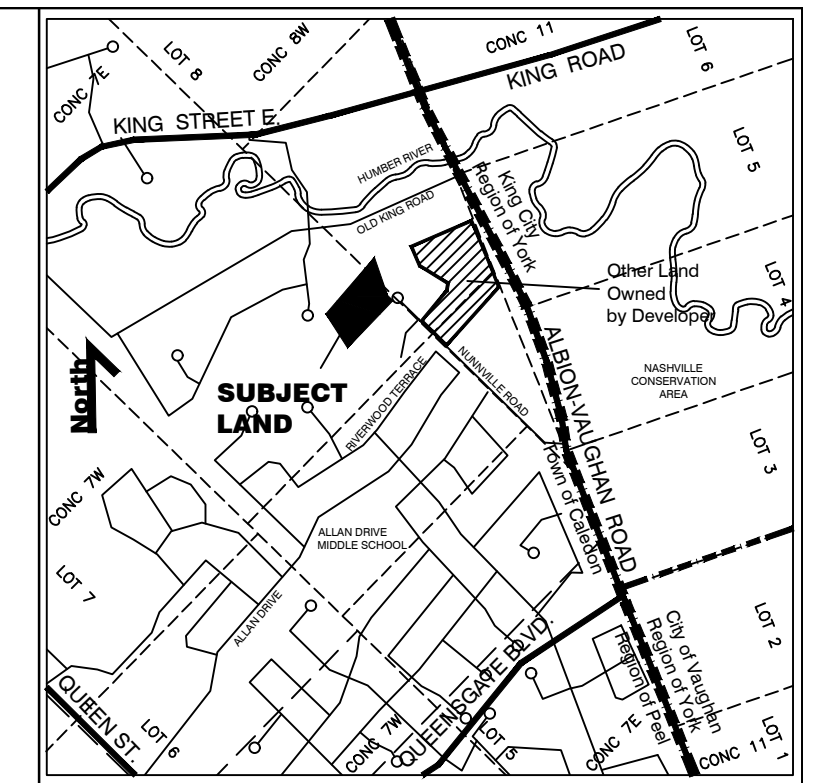


**TOWN OF CALEDON  
PLANNING  
RECEIVED**  
  
**Mar 23, 2023**

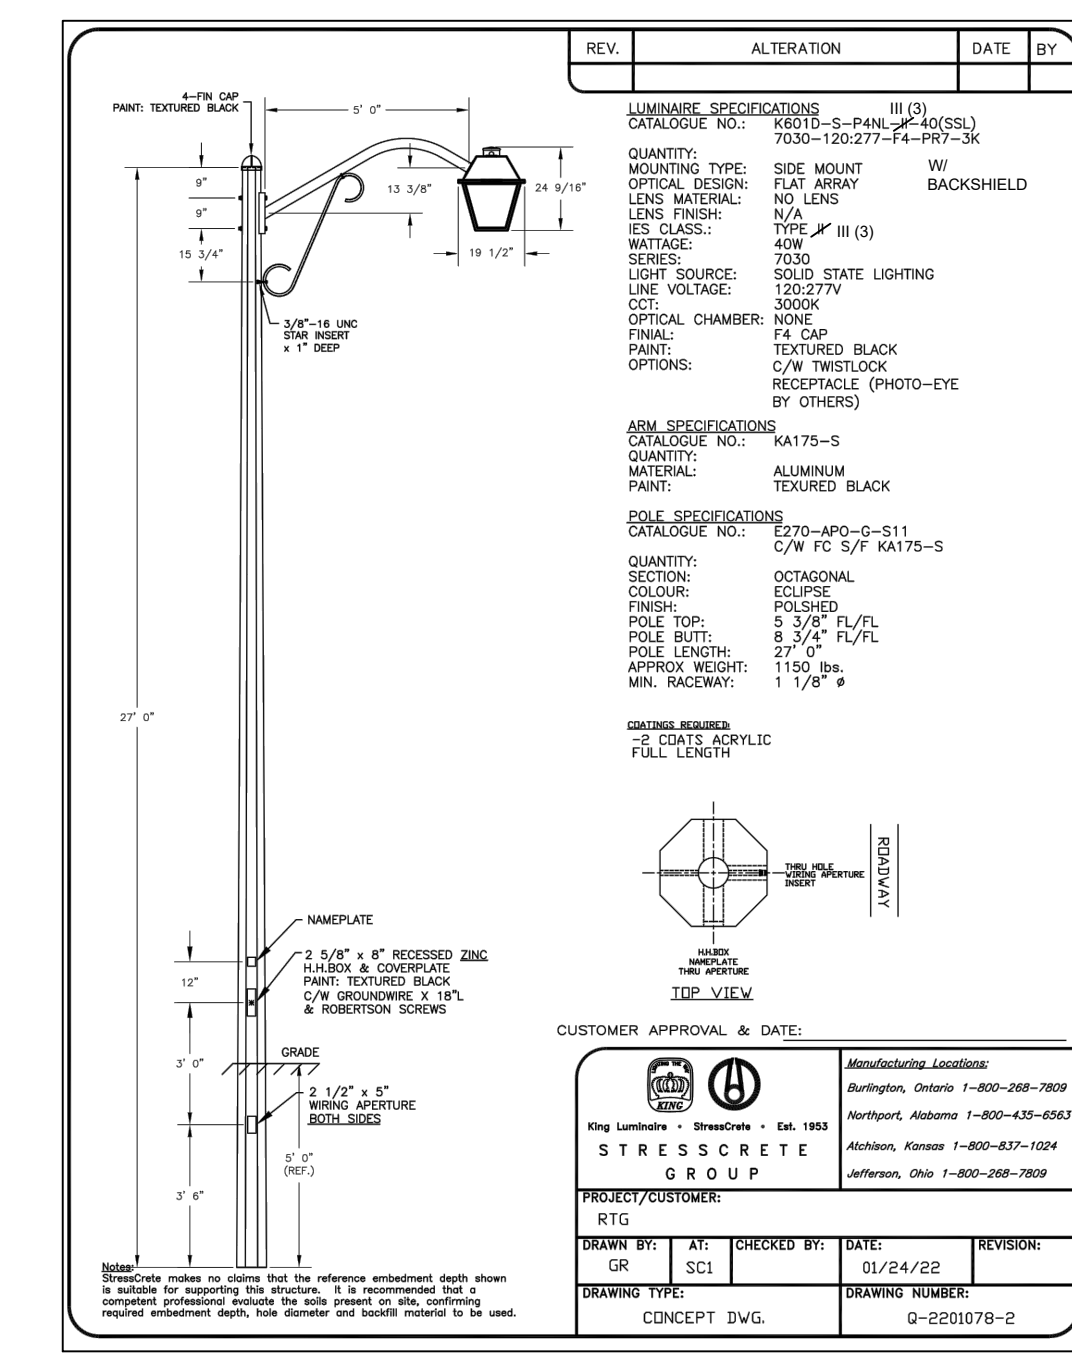


- KEY PLAN N.T.S.
- LEGEND
- SITELIGHT ASSEMBLY  
POLE: 8.2m (27') OCTAGONAL CONCRETE PRESTRESSED AND REINFORCED, BY STRESS-CRETE CAT.# E270-BPO-G-CSA C/W TOP CAP AND FINISHED IN POLISHED MIDNIGHT LACE CAT.# S-10.  
ARM: 1.5m (5') DECORATIVE ARM WITH SCROLL  
LUMINAIRE: KING K601 TYPE III 40W 3000K CAT# K601D-S-III-P4NL-40-(SSL)-7030-120V C/W 7-PIN PHOTO CONTROL AND BACK SHIELD.  
NOTE: LUMINAIRE AND ARM TO BE FACTORY FINISHED POWDER COAT BLACK.
  - AS ABOVE EXCEPT WITH ADDITIONAL SHIELD ON SIDE INDICATED BY \*
  - METERED POWER SUPPLY PEDESTAL TO BE MANUFACTURED BY PEDESTAL SOLUTIONS INC. (PSI), YORK, ONTARIO. CAT.#SLxxx1-#-40, 100A 2 POLE MAIN BREAKER, #-40A BRANCH BREAKERS, PROVISION FOR UP TO 12 BRANCH BREAKERS. WEATHER PROOF, TAMPER PROOF CABINET, DARK GREEN, PROVISIONS FOR PADLOCKS, MOUNT ON PRE-CAST CONCRETE FOUNDATION (USI UP2022 BASE)
  - ++ PROPOSED GROUND ROD.
  - HYDRO ONE TRANSFORMER.
  - STREETLIGHT CABLE: 2-#6RWU C/W 1-#6 RWU GND. CABLE INSTALLED IN 50mm PVC TYPE 2 DIRECT BURIED DUCT IN COMPLETE ACCORDANCE WITH E.S.A. STANDARDS & SPECIFICATIONS
  - STREETLIGHT PEDESTAL SUPPLY CABLE: 3-#2 Cu. RWU-90 C/W JACKETED GND IN CONTINUOUS 50mm PVC TYPE 2 DUCT IN COMPLETE ACCORDANCE WITH E.S.A. STANDARDS & SPECIFICATIONS.
  - ⑭ MUNICIPAL NUMBER
  - HYDRO ONE VAULT.

APPROVED FOR CONSTRUCTION  
THIS APPROVAL CONSTITUTES A GENERAL REVIEW AND DOES NOT CERTIFY DIMENSIONAL ACCURACY.

THIS APPROVAL IS SUBJECT TO THE FURTHER CERTIFICATION OF THE "AS CONSTRUCTED" WORKS BY A REGISTERED PROFESSIONAL ENGINEER OF THE PROVINCE OF ONTARIO.

DATE: \_\_\_\_\_ APPROVED BY: \_\_\_\_\_

NO	REVISION	DATE	BY
1	REVISED PER LATEST SITE PLAN	2023.03.20	

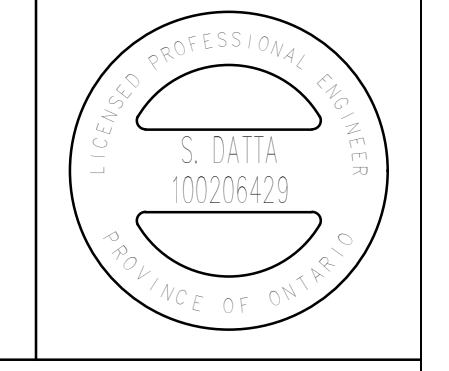

**RTG Systems Inc.**  
ELECTRICAL CONSULTING ENGINEERS  
3518 Mainway Dr., Suite 201 Office: (905) 335-4470  
BURLINGTON ON L7M 1A8 Toronto: (905) 827-7887  
E-MAIL: general@rtgsystems.com

**TOWN OF CALEDON**

**13290 NUNNVILLE ROAD ENCLAVE  
TOWNHOMES  
CONDO SITE LIGHTING**

DWG BY: S.D.	DATE: 2022.04.07	CHK'D BY:	DATE:
SCALE: 1:500	DRAWING NO.:	SHEET 1 OF 1	
EXCEPT SYMBOLS		SL-1	