


NOTES:

1. PROVIDE ALL WORK ASSOCIATED WITH THIS DETAIL. FINISH TO SUIT ARCHITECT'S REQUIREMENTS. EXACT LOCATION OF POLE MOUNTED LUMINAIRES TO BE COORDINATED WITH ARCHITECTURAL SITE PLAN.
2. REFER TO STRUCTURAL CONSULTANT FOR DETAILS OF BASE. THE BASE SHALL BE PROVIDED BY DIVISION 16 IN ACCORDANCE WITH SHOP DRAWINGS, DETAILS AND COORDINATION WITH GENERAL CONTRACTOR AND DIVISION 3.
3. ELECTRICAL CONTRACTOR TO PROVIDE MINIMUM SIZE OF WIRING 2#10+GND IN 1".

NOTES:

1. PROVIDE 5" POLE TO SUIT.
2. HEIGHT TO CENTER OF LUMINAIRE OPTICS.

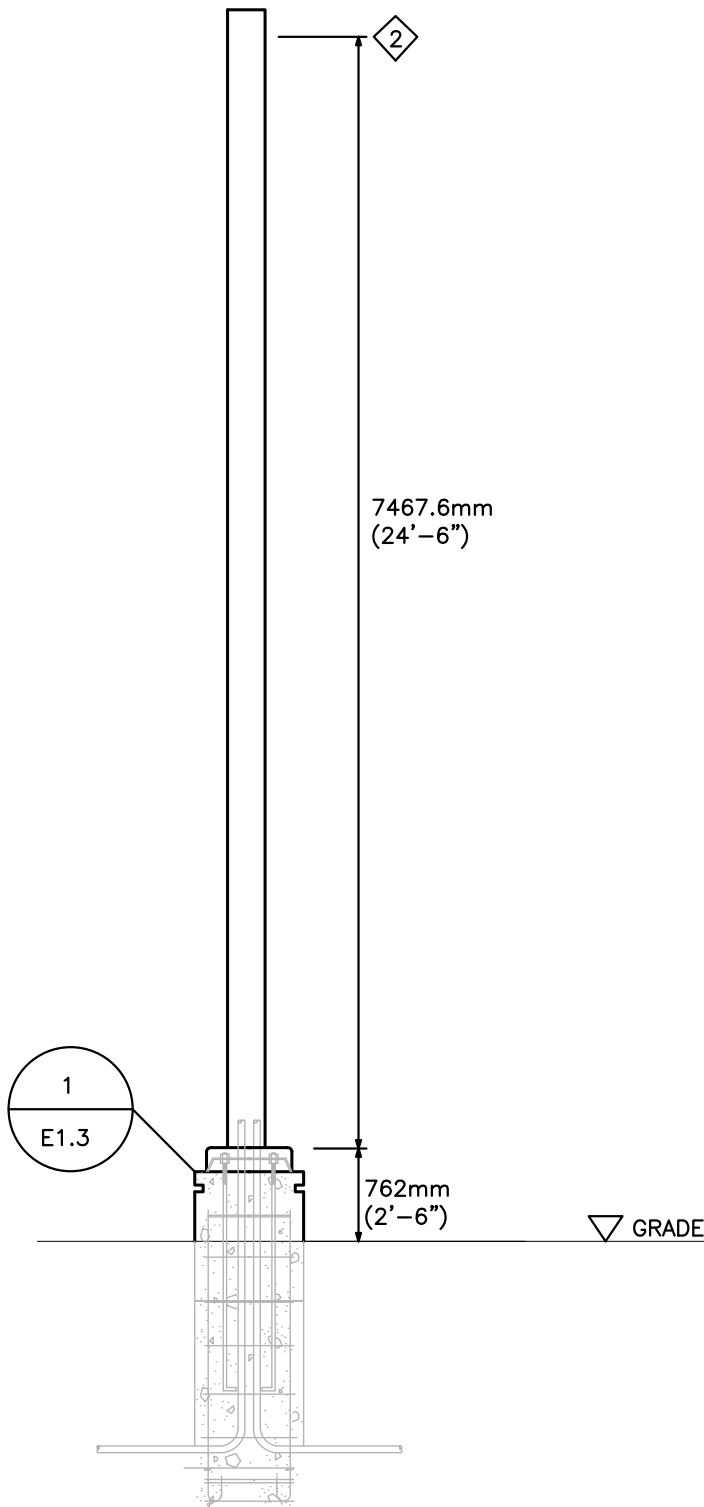

LUMINAIRE SCHEDULE						
SYMBOL	LABEL	ARRANGEMENT	TOTAL LAMP LUMEN	LLF	MANUFACTURER	WATTAGE
	LA1	POLE MOUNTED	17,683	1	Lithonia Lighting DSX1 LED P6 30K T3M BLC MVOLT SPA DDBXD C/W 4SS-20-BRONZE DOUBLE DRILLED AT 180° AB75	326
	LA2	POLE MOUNTED	14,489	1	Lithonia Lighting DSX1 LED P6 30K BLC MVOLT SPA DDBXD C/W HOUSE SHIELD AND 4SS-20-BRONZE	163
	LA3	POLE MOUNTED	19,983	1	Lithonia Lighting DSX1 LED P7 30K T5M MVOLT SPA DDBXD DOUBLE DRILLED AT 180° AB75	276
	LA4	POLE MOUNTED	18,348	1	Lithonia Lighting DSX1 LED P6 30K T5M MVOLT SPA DDBXD C/W 4SS-20-BRONZE	163
	LA5	POLE MOUNTED	6,770	1	Lithonia Lighting DSX1 LED P2 30K BLC MVOLT SPA DDBXD C/W 4SS-20-BRONZE	70
	LA6	POLE MOUNTED	26,406	1	Lithonia Lighting DSX1 LED P6 30K T5W MVOLT SPA DDBXD C/W 4SS-20-BRONZE, HOUSESHIELD	241
	LA7	POLE MOUNTED	10,781	1	Lithonia Lighting DSX1 LED P6 30K RCCO MVOLT SPA DDBXD C/W 4SS-20-BRONZE	163
	LB1	POST TOP	4598	1	HOLOPHONE PUCL2-UTILITY TAFT LED FCO P20-30K-BX-L5-S	45
	LB2	POST TOP	4510	1	HOLOPHONE PUCL2-UTILITY TAFT LED FCO P20-30K-BX-L4-S	45

STATISTICS

DESCRIPTION	UNITS	AVG	MAX	MIN	MAX/MIN	AVG/MIN
PARKING LOT	Fc	1.8	6.0	0.2	30.0:1	9.0:1
BACK LOT	Fc	0.0	1.0	0.0	N/A	N/A
GARDEN AREA	Fc	2.7	6.8	0.1	68.0:1	27.0:1
LIGHT TRESSPASS	Fc	0.0	2.1	0.0	N/A	N/A
DRIVEWAY	Fc	1.5	3.7	0.2	18.5:1	7.5:1

1 LIGHTING POLE BASE DETAIL

SCALE: N.T.S.

2 POLE DETAIL

SCALE: N.T.S.


3 LUMINAIRE SCHEDULE

SCALE: N.T.S.



NOTES:

1. PROVIDE 4" POLE TO SUIT.

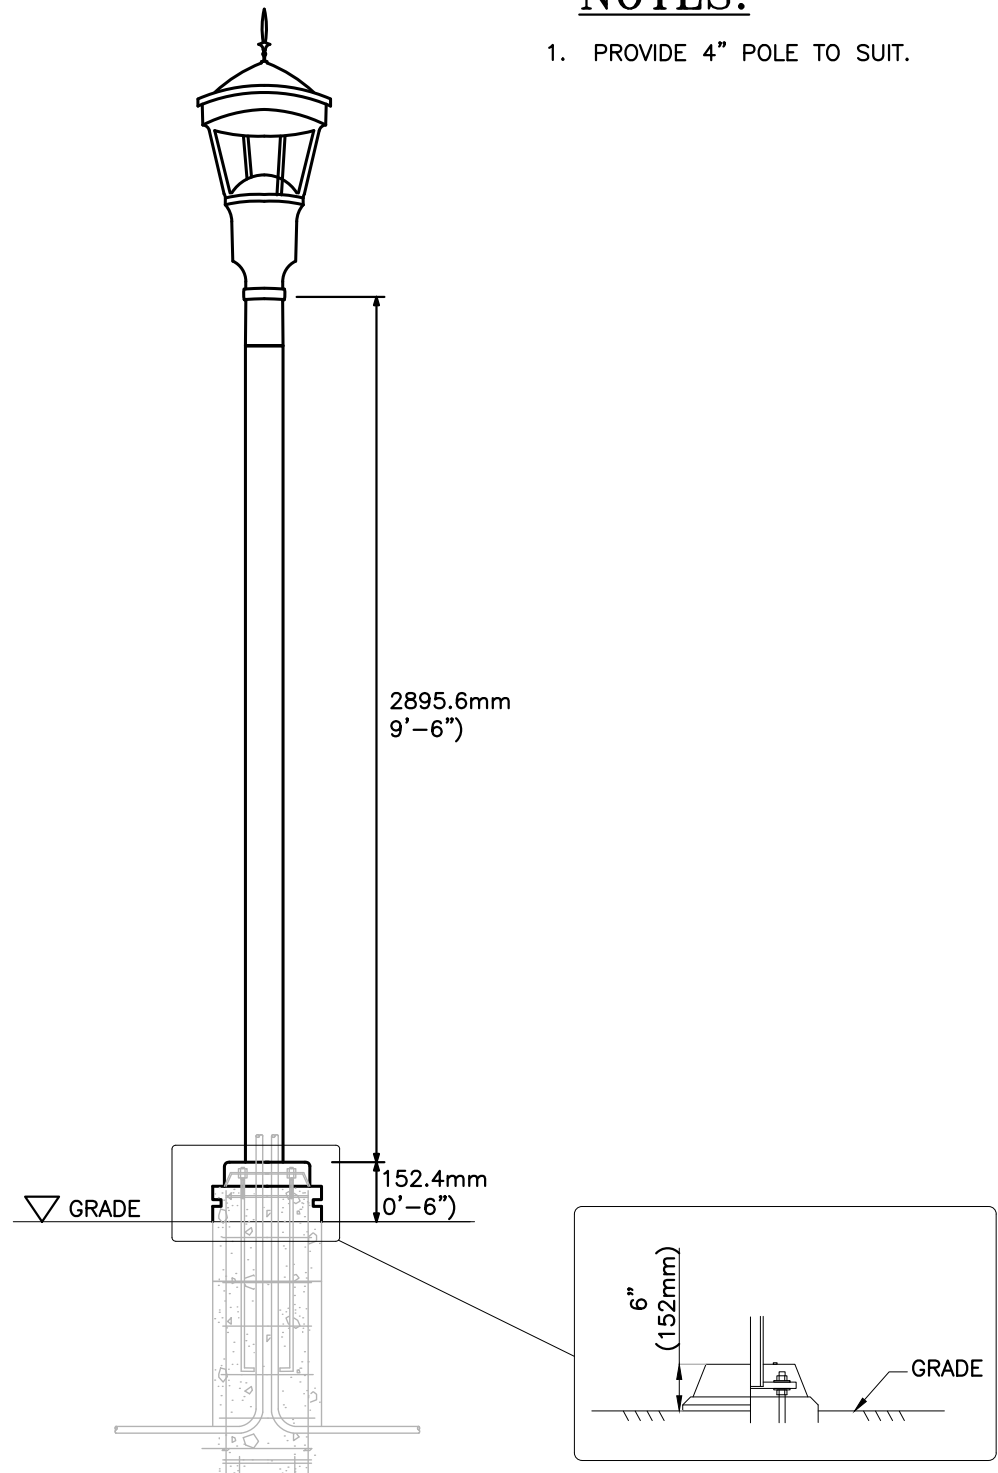

5 LUMINAIRE TYPE 'LB1' & 'LB2'

SCALE: N.T.S.



6 LUMINAIRE TYPE 'LB1' & 'LB2'

SCALE: N.T.S.

4 POLE MOUNTED LUMINAIRES

SCALE: N.T.S.



2. RE-ISSUED FOR SPA/SPA	20/11/16	AM
1. ISSUED FOR SPA/SPA	20/09/25	AM

The contractor shall check and verify all dimensions and report all errors and omissions to the Architect before proceeding with the work. This drawing is the property of the Architect and must be returned on completion of the work. Do not scale drawings.

BATTAGLIA
ARCHITECT INC.
1000 McIntosh Avenue Unit 14 Scarborough, On. M1W 2L8
T: 416-462-7772 F: 416-466-7967
e-mail: battagliaarchitect@gmail.com
www.battagliaarchitect.com

Drawing
SITE PLAN DETAILS

Scale
N.T.S.
Drawn By
U.A.
Project no.
20-100
Drawing no.
E1.3