

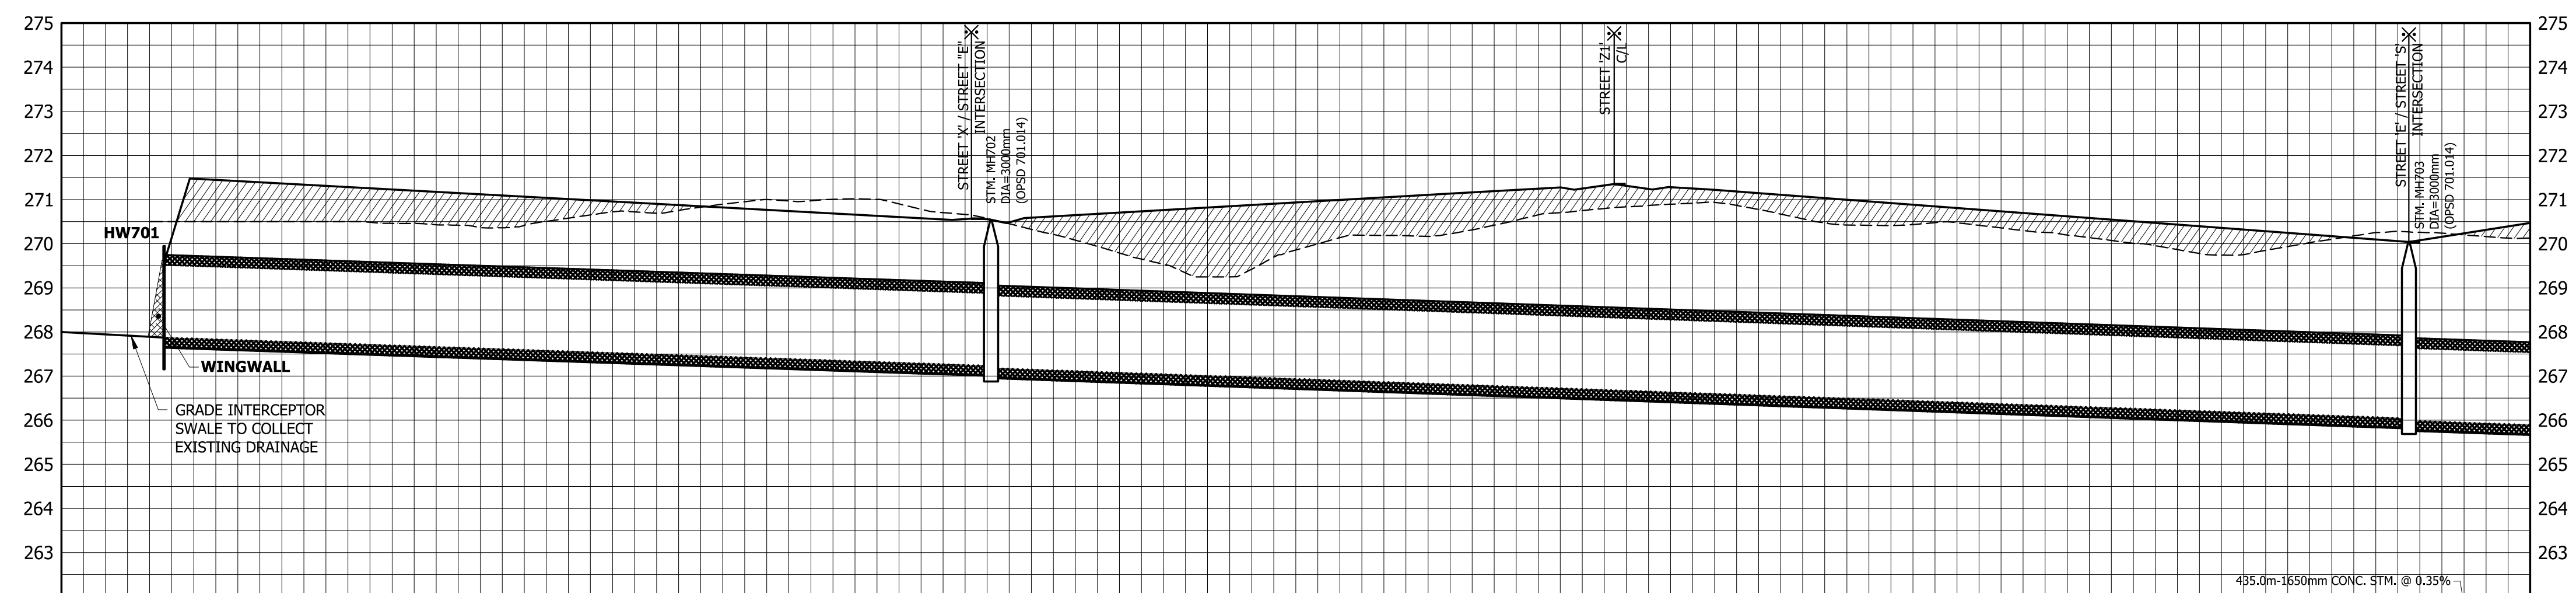


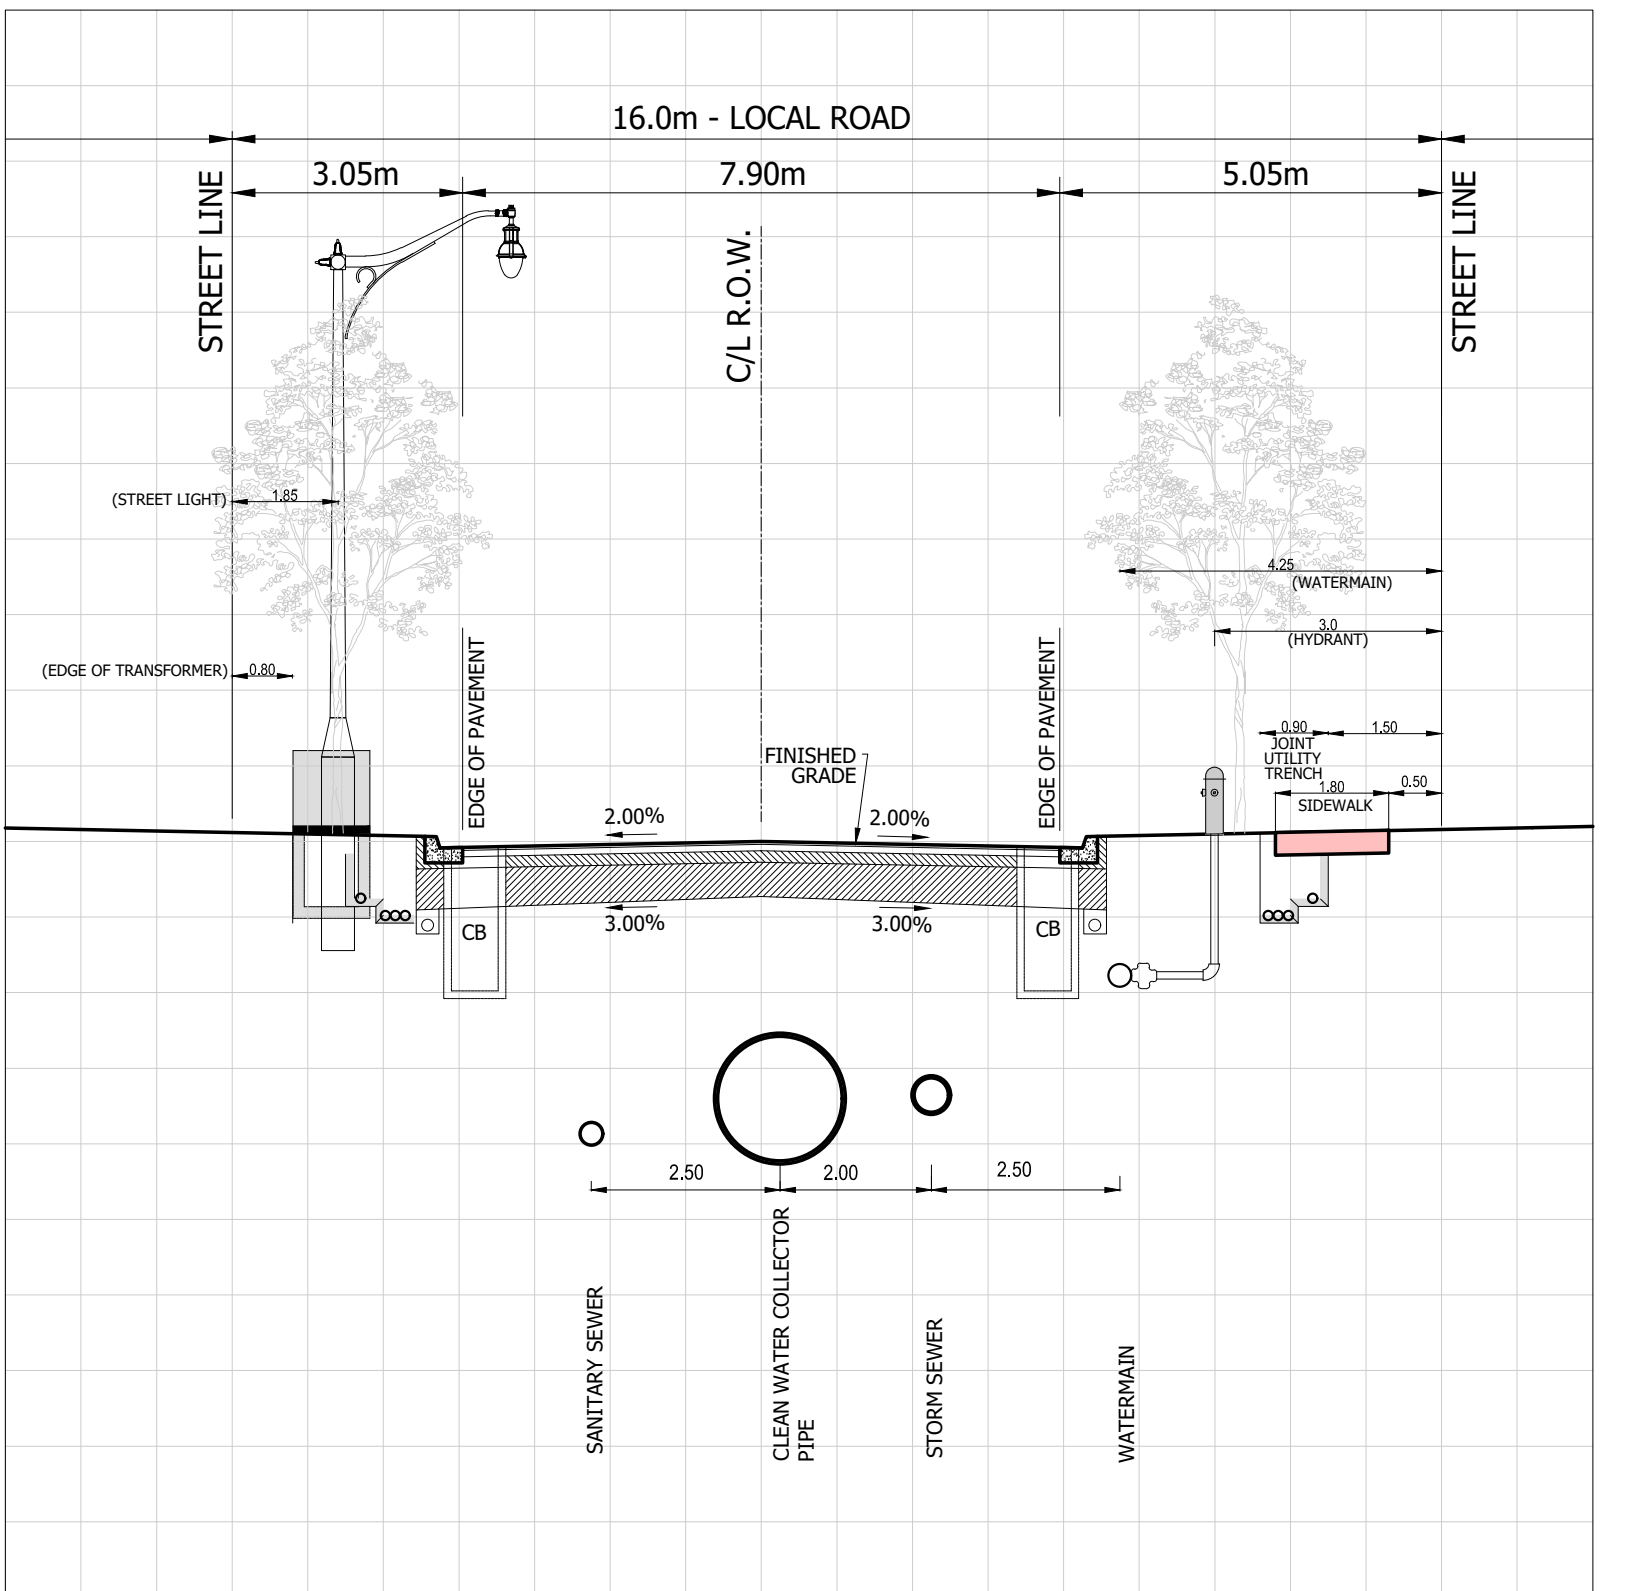

CLEAN WATER COLLECTOR PIPE

(STA 0+540 TO 1+080)

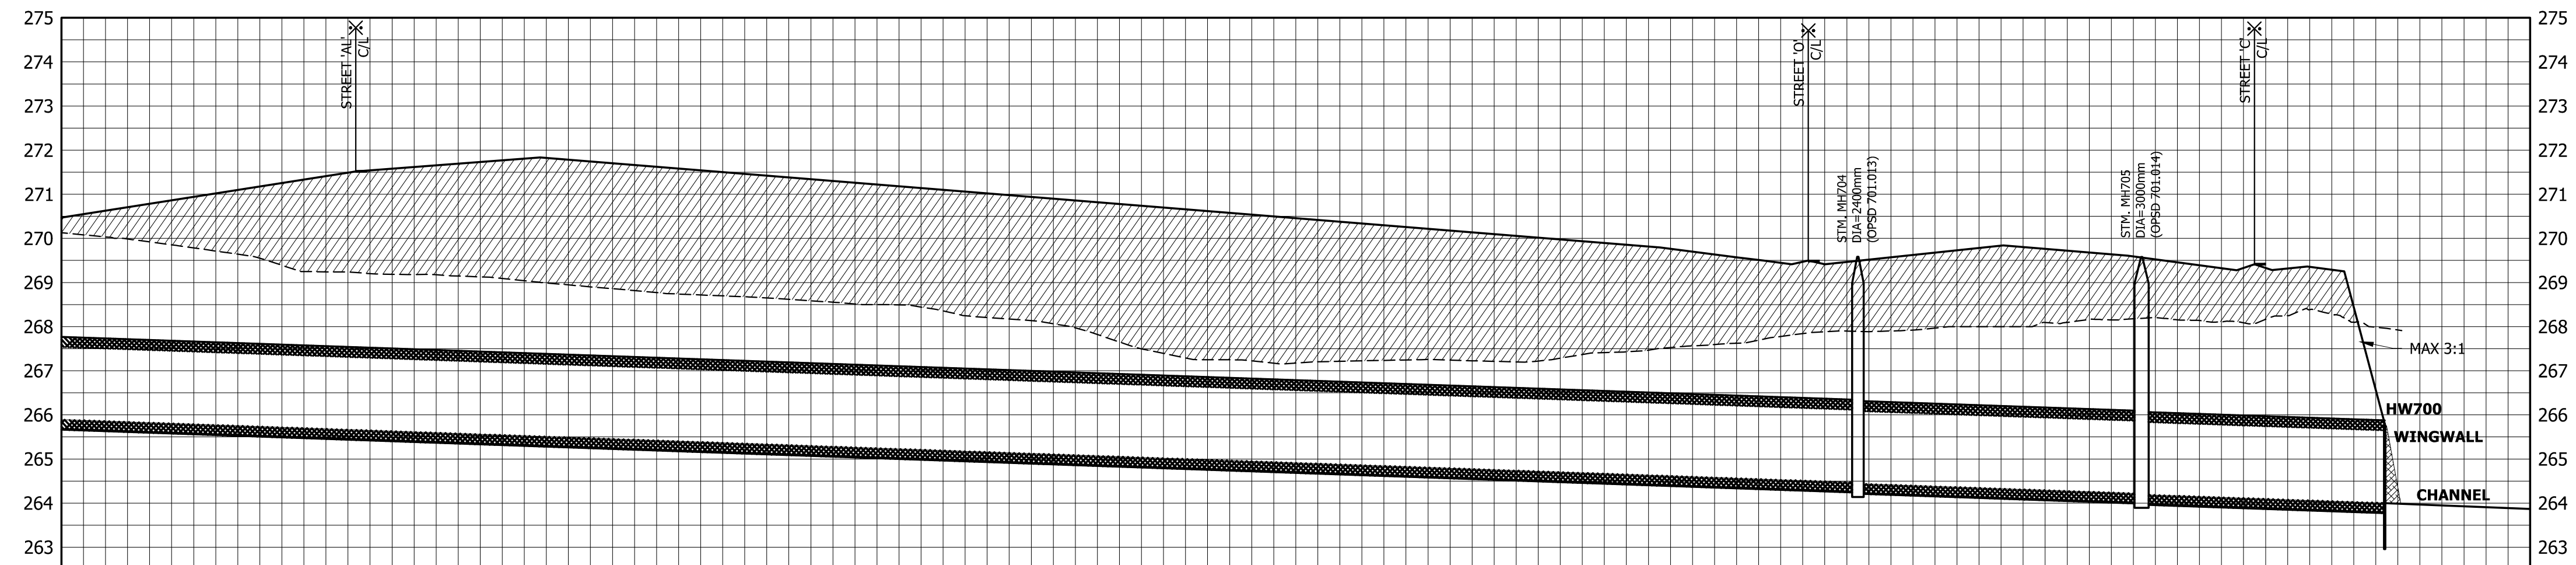

16.0m ROW CROSS SECTION WITH CWC
(TYPICAL DETAIL)

- | | |
|--------|---|
| NOTES: | |
| 1. | REFER TO GRADING PLANS FOR PRELIMINARY CENTERLINE GRADES. |
| 2. | REFER TO DRAWING 502 FOR PRELIMINARY PLAN VIEW DESIGN. |



**TOWN OF CALEDON
REGIONAL MUNICIPALITY OF PEEL
MACVILLE SECONDARY PLAN
(BRES OPTION 3 LANDS)**

PRELIMINARY CLEAN WATER COLLECTOR (CWC) PROFILE

SURVEYED BY: J.D.B.		DATE: 2020		JOB NO. 15-458	
DRAWN BY: V.P.		CHECKED BY: D.Z.		DRAWING NO. 504 SHEET NO.	
DESIGNED BY: D.Z.		CHECKED BY: D.Z.			
SCALE: V 1:100 H 1:1000		DATE: JAN. 2021			